






REAR ELEVATION

SCALE: 1/4" = 1'

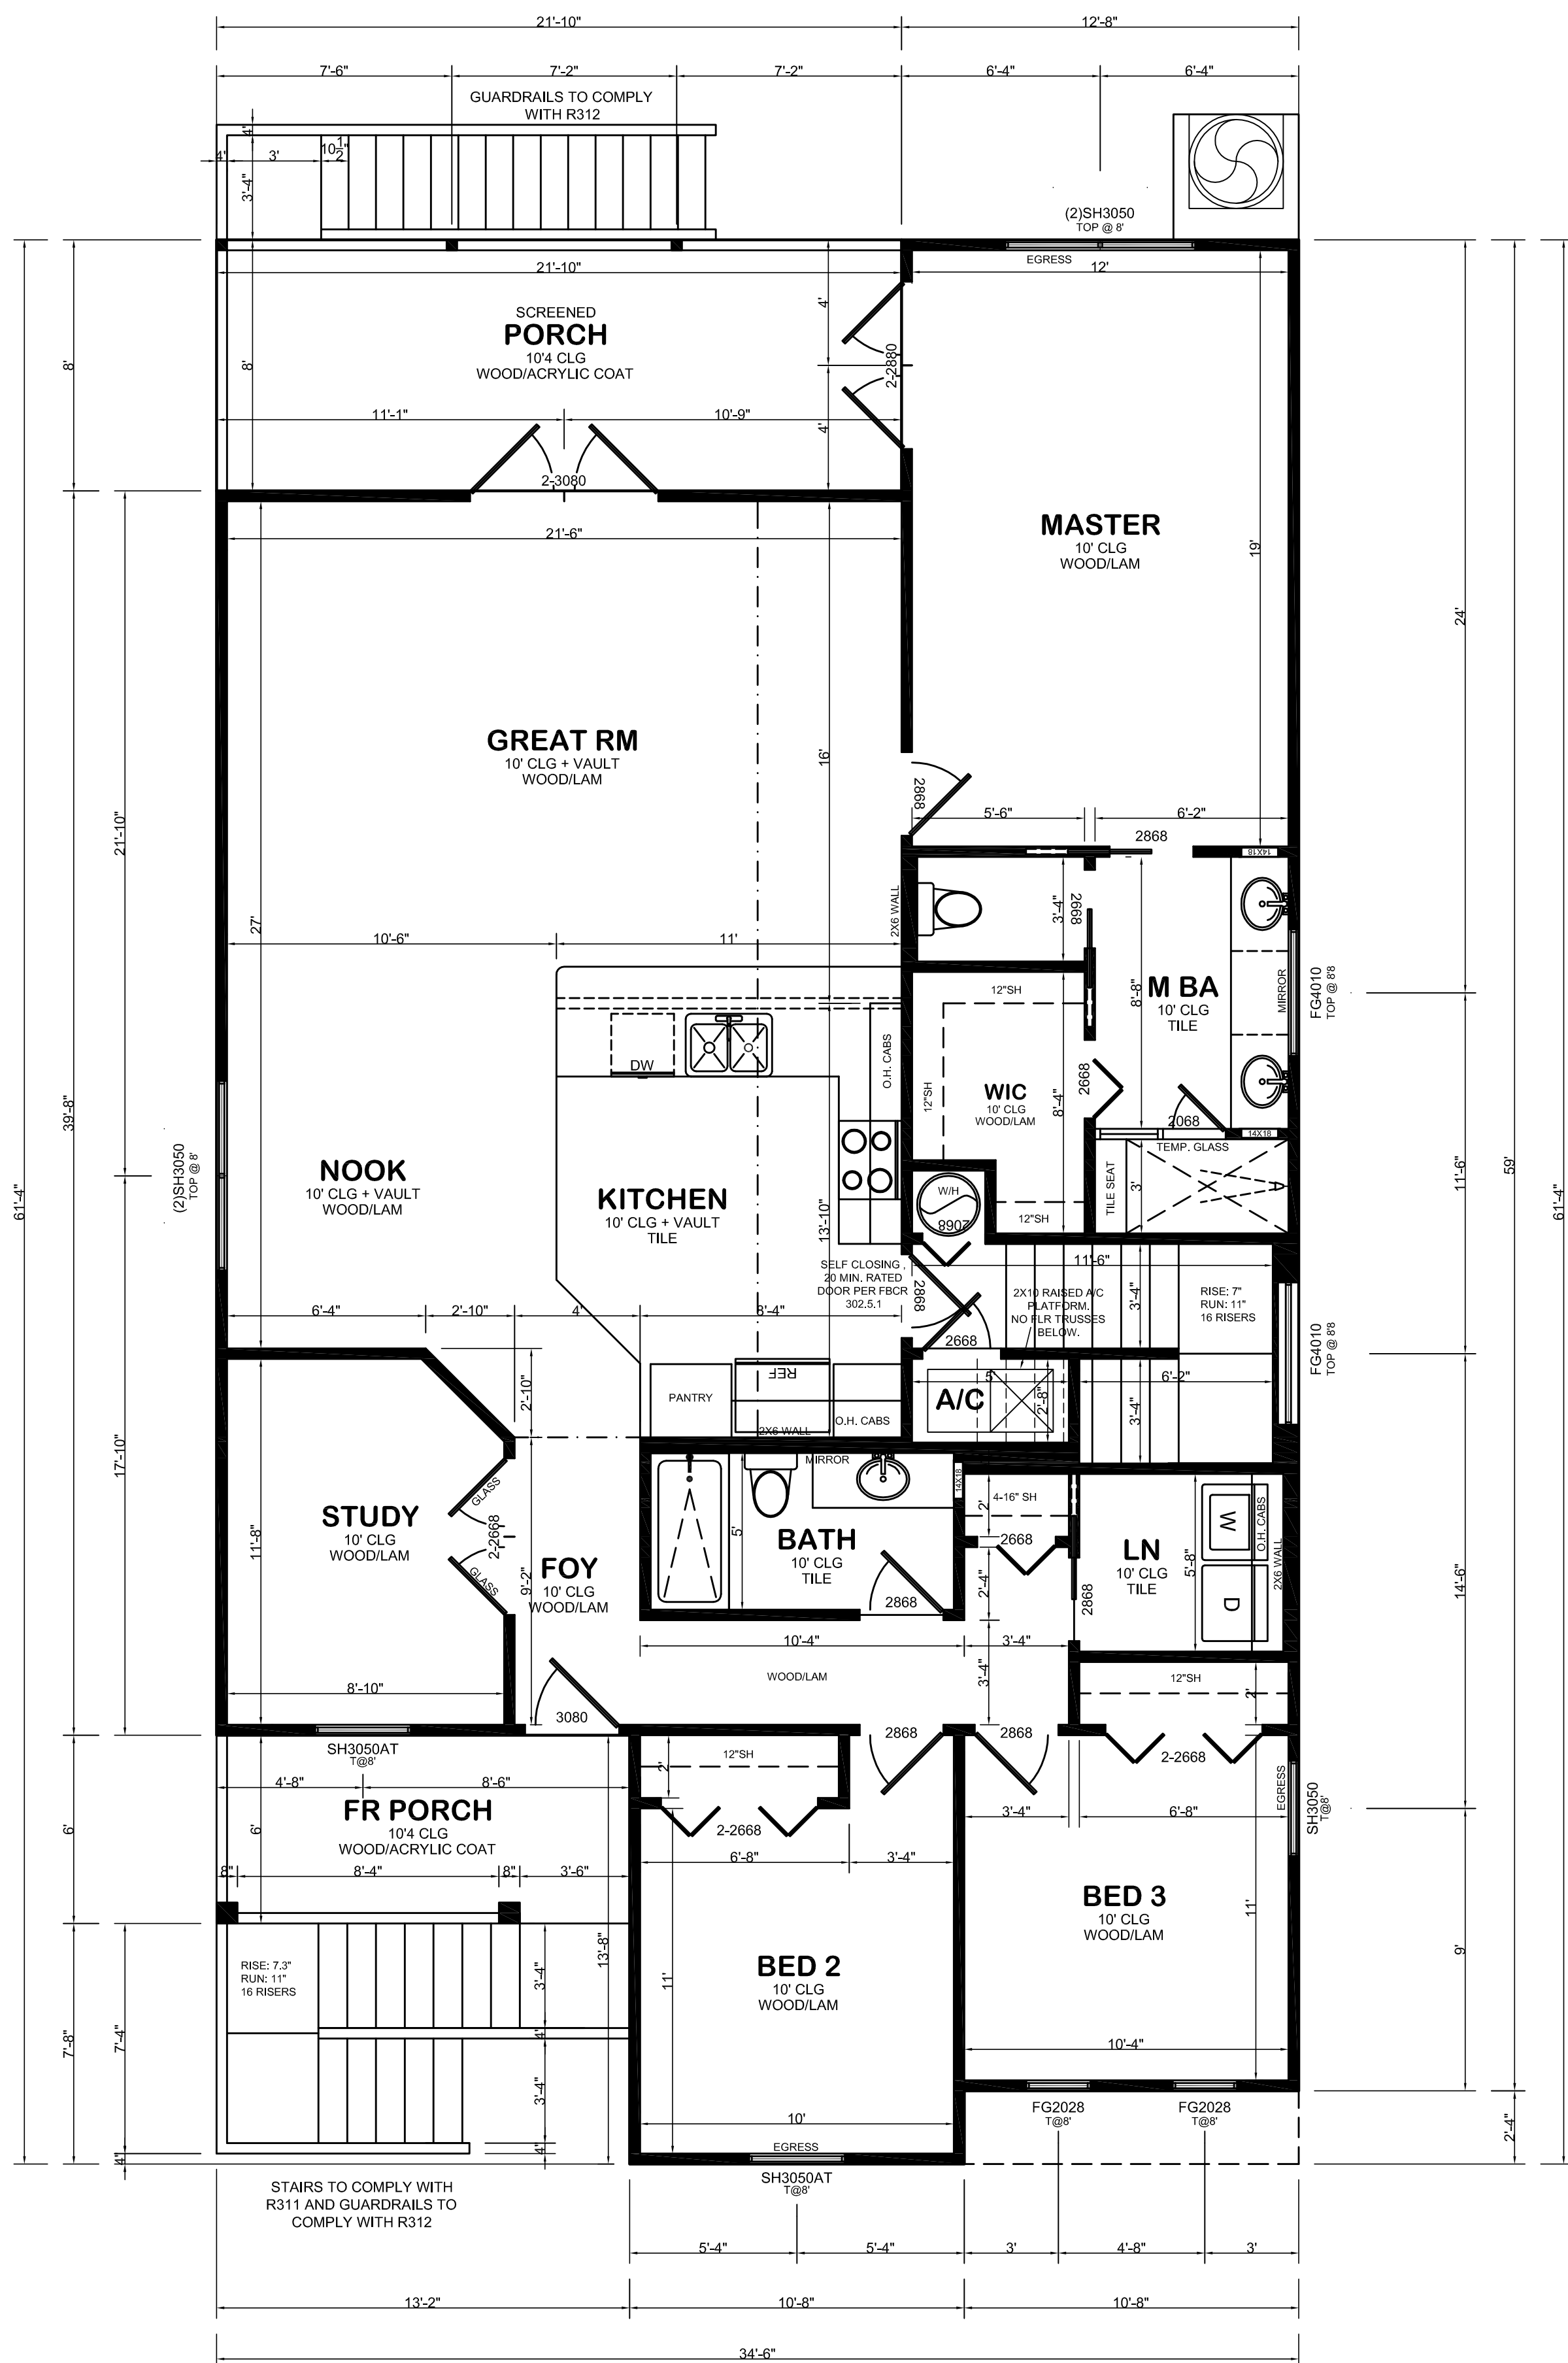

SHEET
2
OF 5

Michael Borremans
FL. Reg. #73068
Cert. Au. #29659
3140 W. Kennedy Blvd, Suite #120
Tampa, FL 33609
Phone: (813)629-0711
Fax: (352)593-5223

© DRAWINGS ARE THE INTELLECTUAL PROPERTY OF CURTIS R. MORGAN.
ANY REPRODUCTION OR UNAUTHORIZED USE IS PROHIBITED.




David Williams

ALL ELECTRICAL MUST BE IN COMPLIANCE WITH NFPA 70A, NATIONAL ELECTRICAL CODE REQUIREMENTS FOR ONE AND TWO FAMILY DWELLINGS, EXCEPT ARTICLE 80.

PROVIDE ARC-FAULT INTERRUPTERS IN ALL DWELLING UNIT BEDROOMS PER NEC, SECTION 210-12.

ALL OUTSIDE W.P. OUTLETS TO BE ON THERE OWN 20AMP CIRCUIT.

- CEILING OUTLET FIXTURE
- PULL CHAIN FIXTURE
- WALL MOUNT FIXTURE
- FAN PREWIRE FIXTURE
- RECESSED OUTLET FIXTURE
- VENT FAN FIXTURE
- DUAL W.P. FLOOD FIXTURE
- DUPLEX OUTLET
- GROUND FAULT OUTLET
- 1/2 SWITCH OUTLET
- 220V OUTLET
- WATER PROOF OUTLET
- SINGLE POLE SWITCH
- 3-WAY SWITCH
- 4-WAY SWITCH
- DIMMER SWITCH
- LOW VOLTAGE SWITCH
- WATERPROOF SWITCH
- GARBAGE DISPOSAL SWITCH
- TELEPHONE
- SMOKE /CARB. MON. DET.
- TELEVISION OUTLET
- DOORBELL CHIME
- METER W/GROUNDING ROD
- SERVICE PANEL

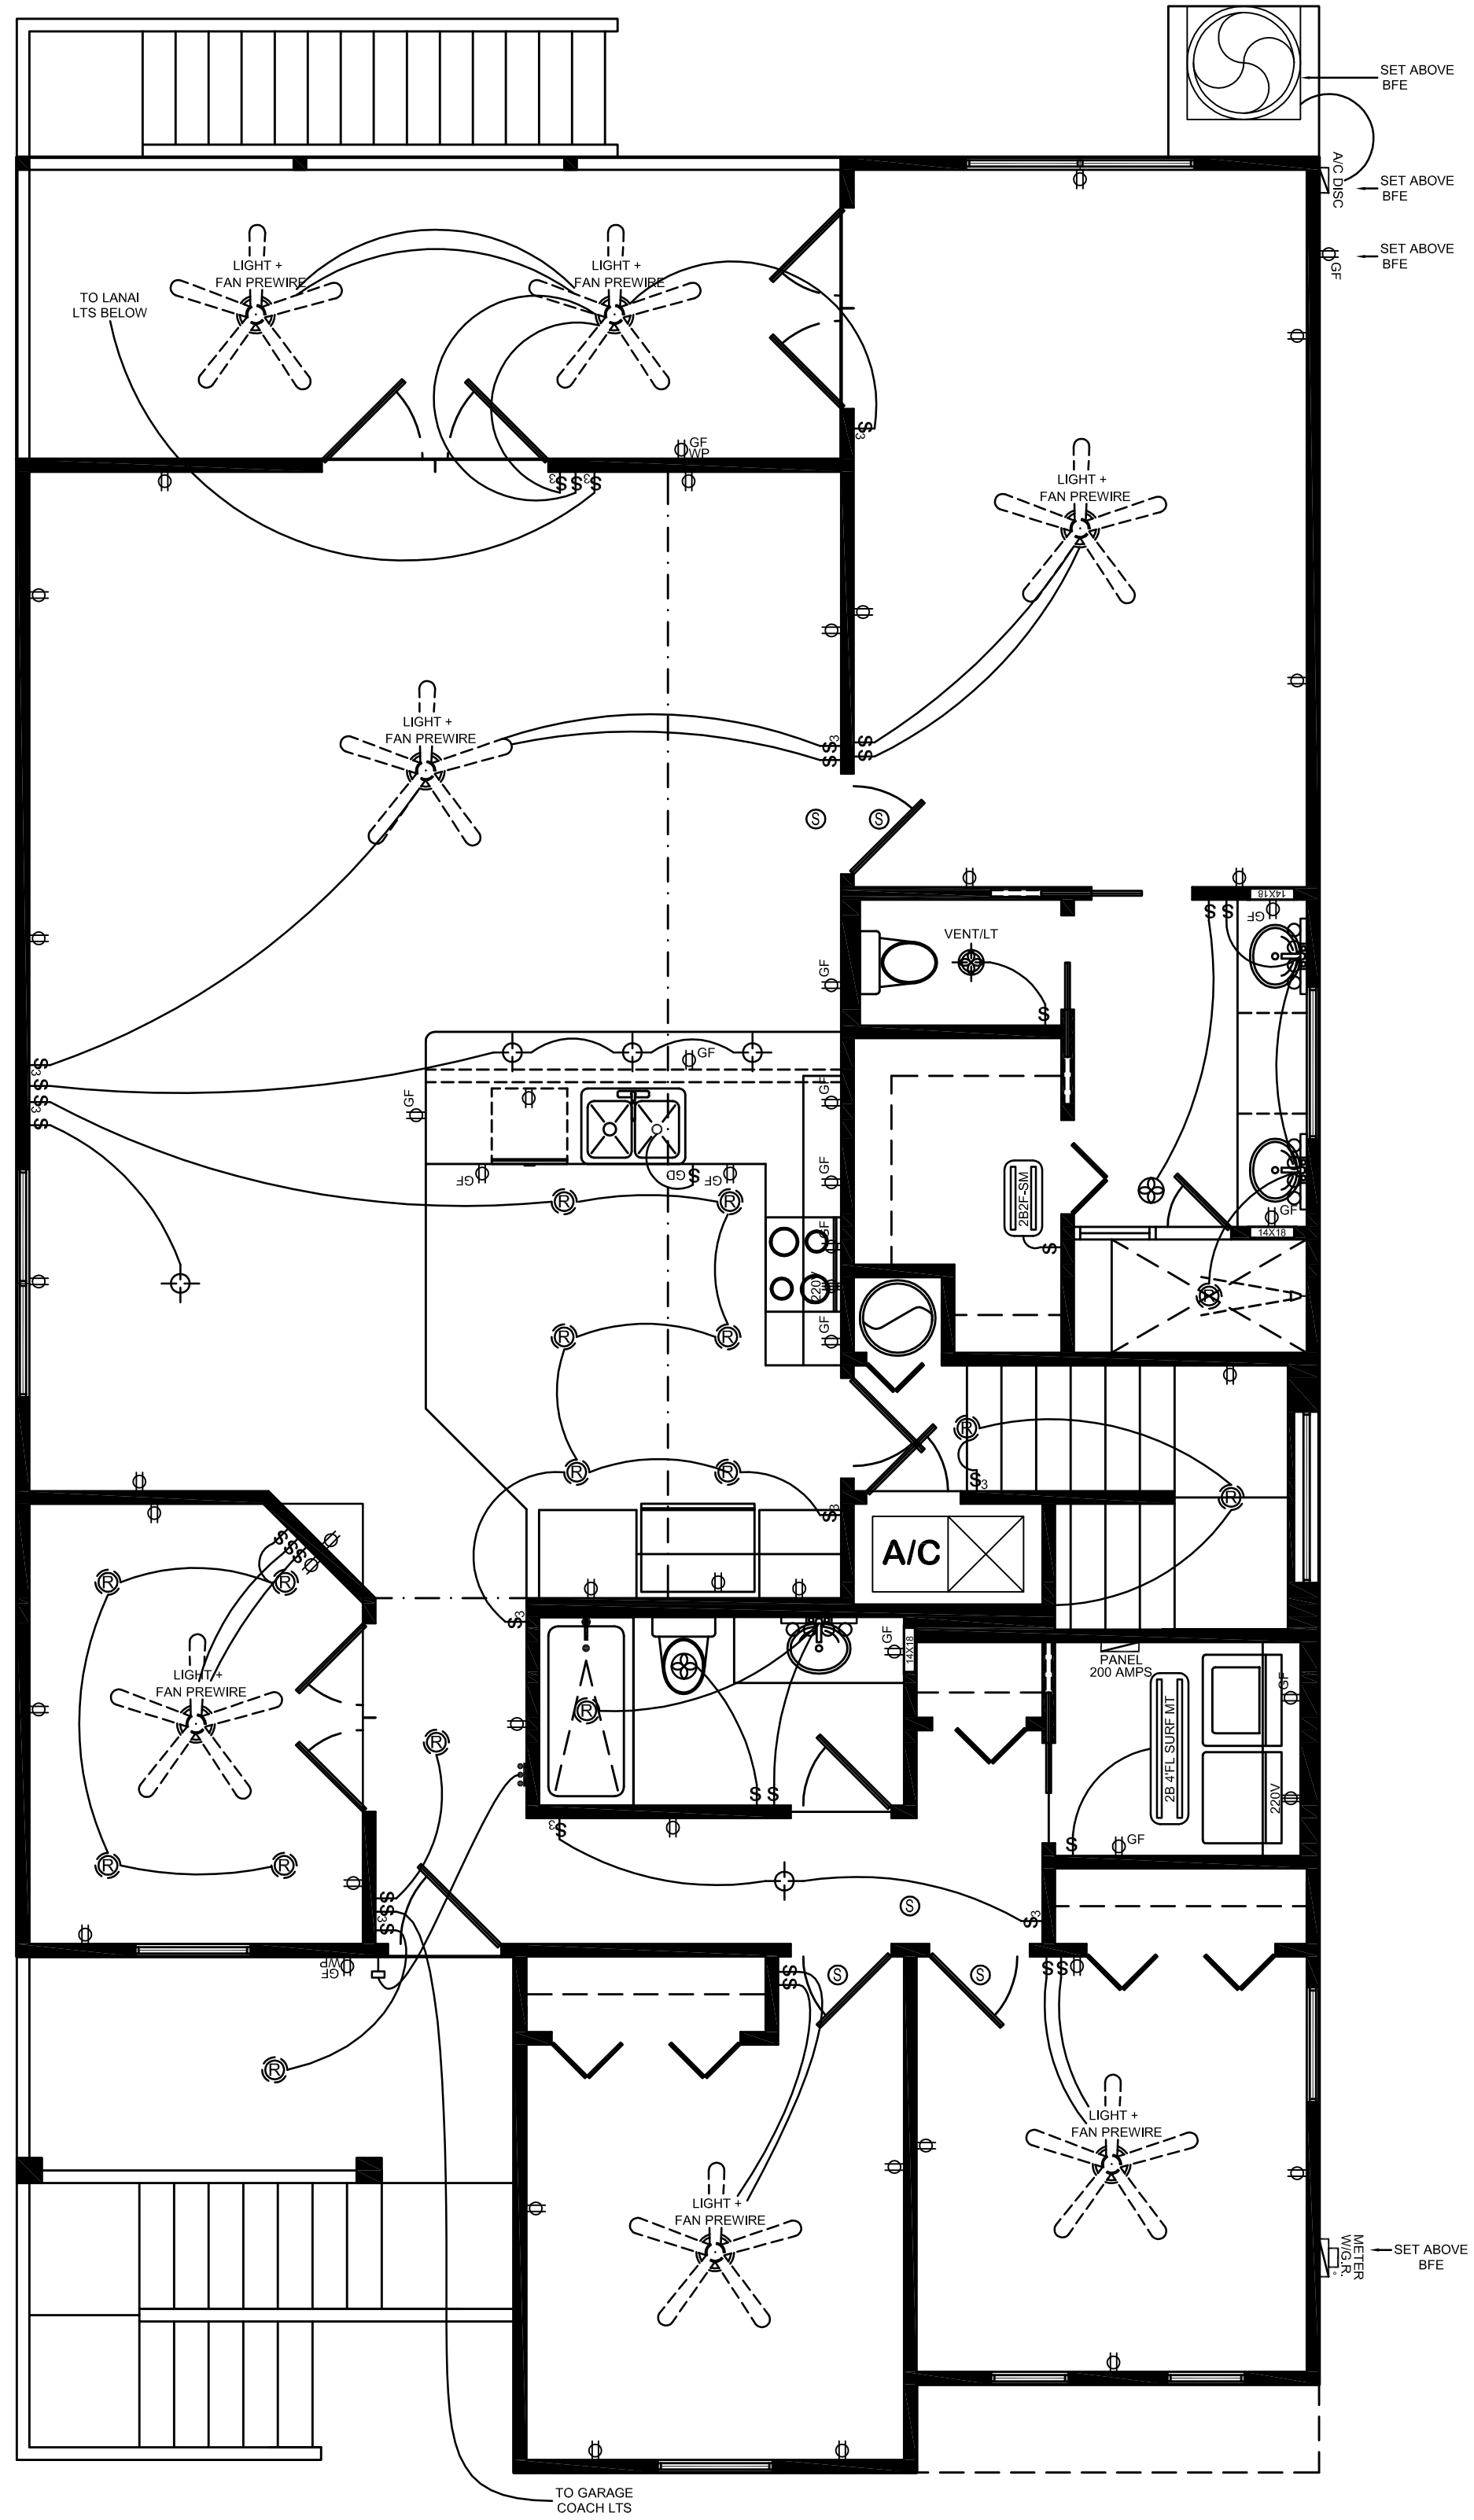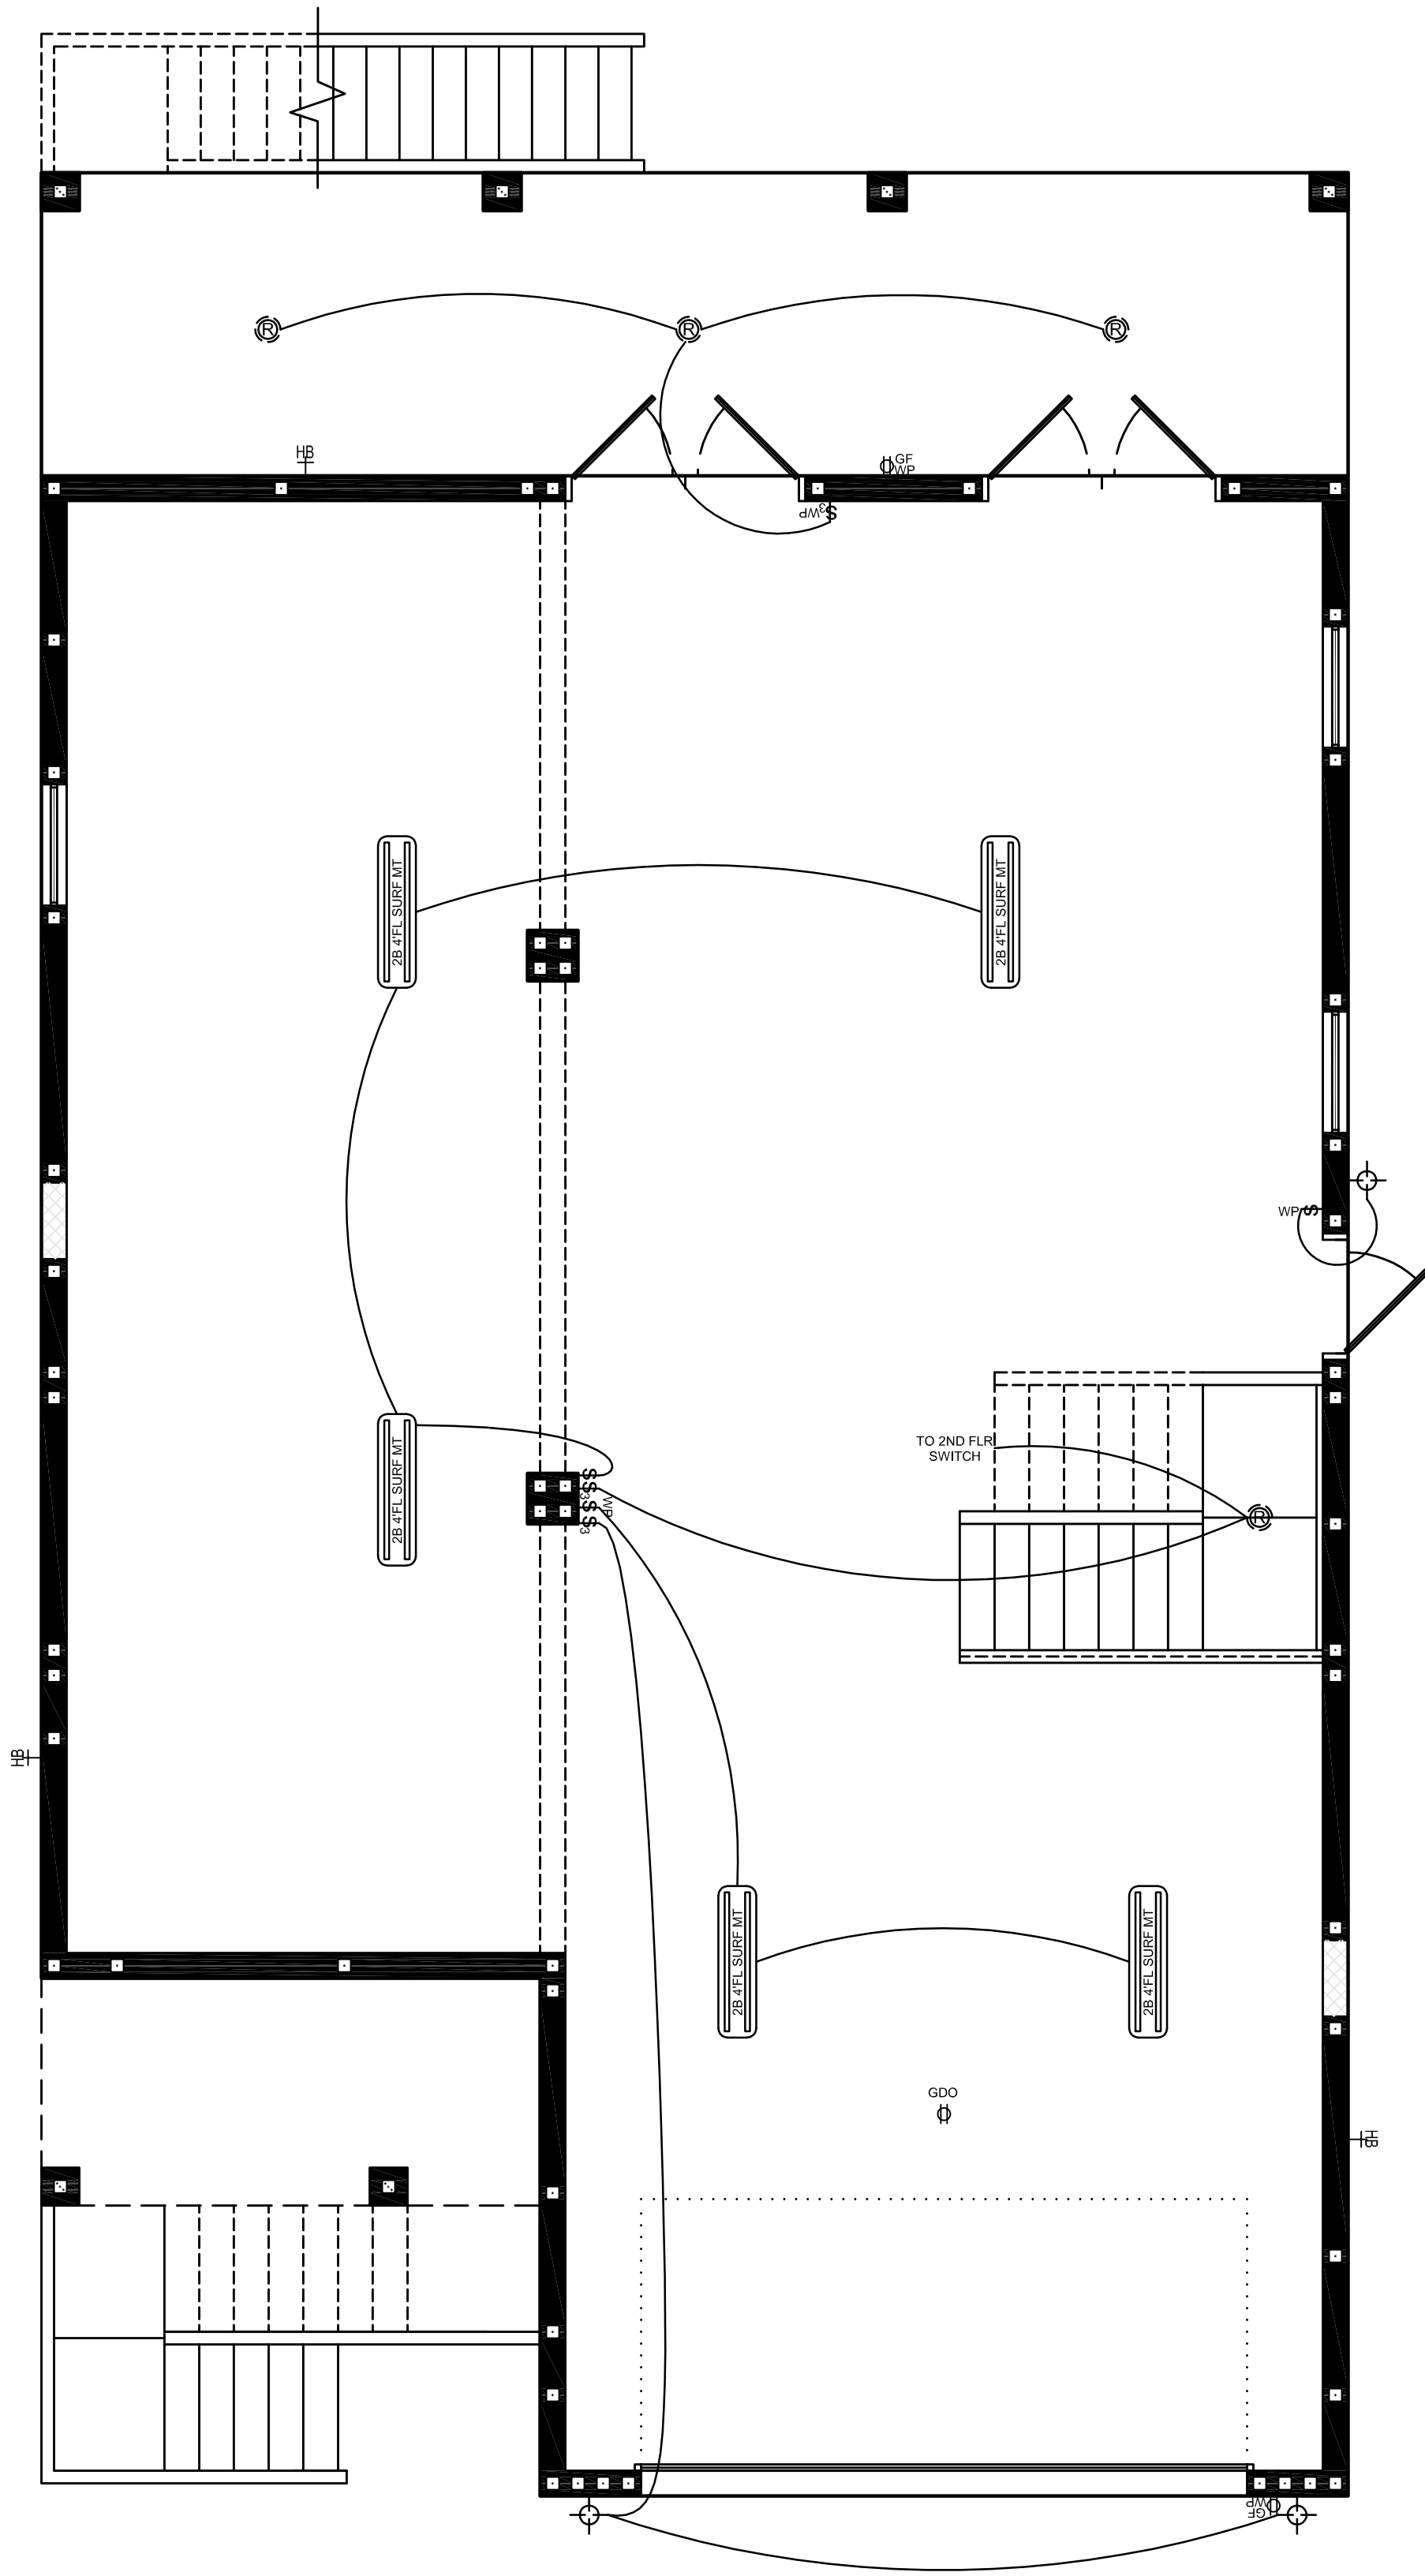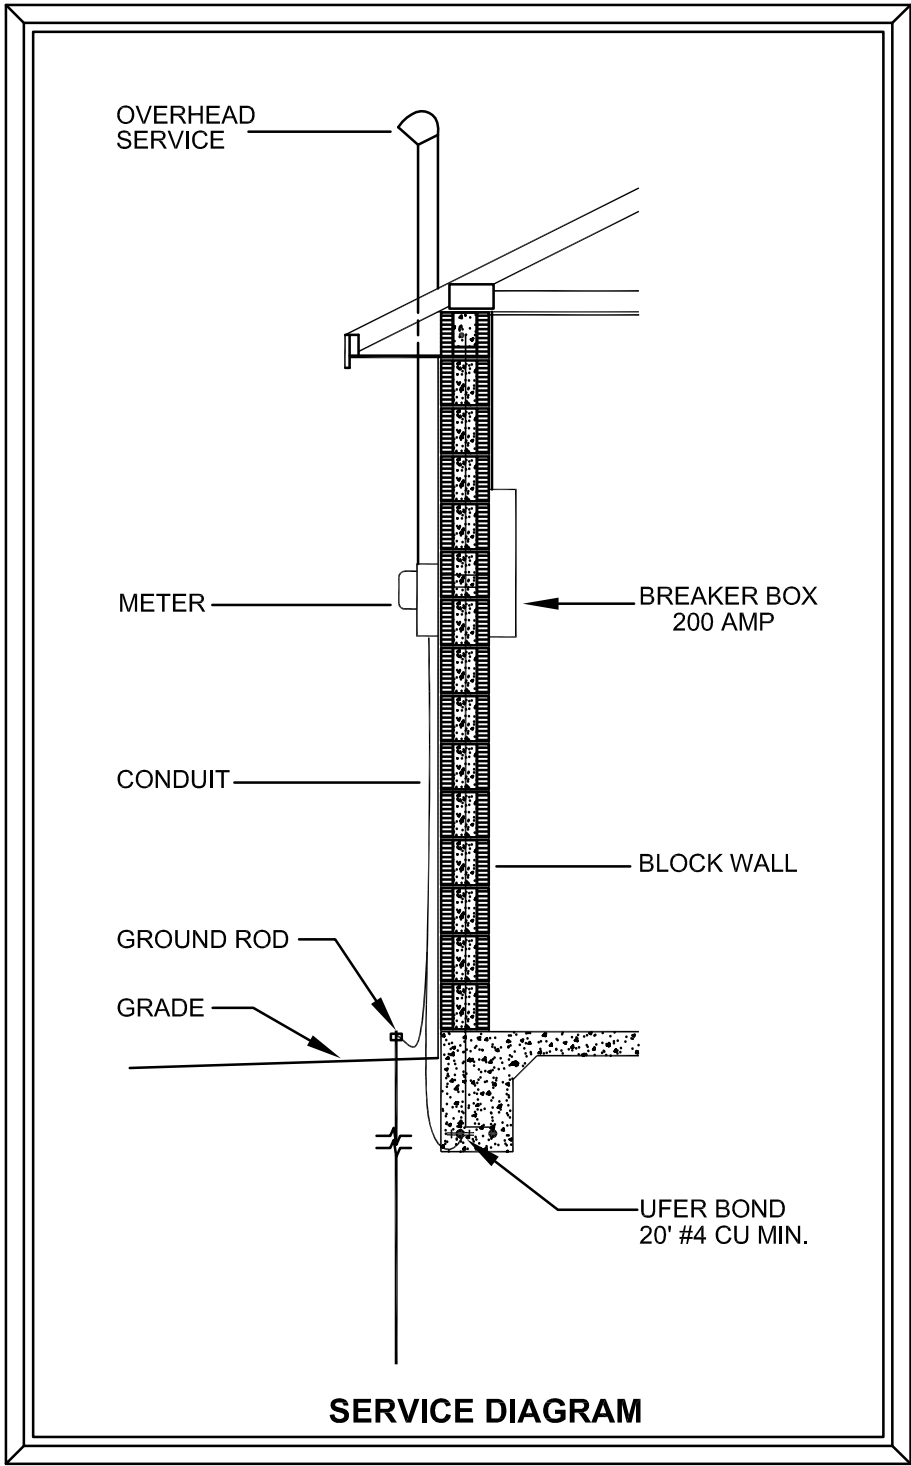

David Williams

ELECTRICAL

SCALE: 1/4" = 1'

LABUA BY MORGANCASTLE STUDIOS, INC.

DEV: CRYSTAL BEACH COUNTY: PINELLAS

LOT: 205 AVERY AVE. PLAN STATUS: FINAL FOR REVIEW

DATE	REVISION	DESIGNER
5-9-17	PLANS FOR PERMIT	CM

MODEL: OCTAVIA C.A.D. #: LABUA

SHEET 3 OF 5